

SITE CONSTRUCTION PLANS

Central Baptist Church

SECTION 2, TOWNSHIP 2 SOUTH, RANGE 24 WEST
OKALOOSA COUNTY, FLORIDA

UTILITY COMPANIES

CONTRACTOR SHALL HAVE ALL EXISTING BURIED UTILITIES "LINE SPOTTED" BY CALLING 1-800-432-4770 "CALL SUNSHINE" OR BY CONTACTING LOCAL UTILITY COMPANIES.

- WATER: OKALOOSA COUNTY WATER & SEWER
1804 LEWIS TURNER BLVD., SUITE 300
FORT WALTON BEACH, FLORIDA 32547
PHONE: 850-651-7171
- SEWER: OKALOOSA COUNTY WATER & SEWER
1804 LEWIS TURNER BLVD., SUITE 300
FORT WALTON BEACH, FLORIDA 32547
PHONE: 850-651-7171
- TELEPHONE: EMBARQ
SOUTHERN OPERATIONS
650 DENTON BOULEVARD
FT. WALTON BEACH, FL 32547
PHONE: 850-664-3751
800-488-2201
- TV CABLE: COX COMMUNICATIONS INC.
320 N.W. RACETRACK ROAD
FT. WALTON BEACH, FL 32547
PHONE: 850-796-1269
- ELECTRIC: GULF POWER COMPANY
140 S.W. HOLLYWOOD BOULEVARD
FT. WALTON BEACH, FL 32548
PHONE: 225-5797


LEGAL DESCRIPTION:
STATE OF FLORIDA:
COUNTY OF OKALOOSA:

LOTS 1, 2 AND 28, BLOCK "C", RACETRACK ROAD SUBDIVISION AND LOTS 3 AND 7, BLOCK "C", RE-SUBDIVISION RACETRACK ROAD OKALOOSA COUNTY FLORIDA, SECTION 2, TOWNSHIP 2 SOUTH, RANGE 24 WEST, RECORDED PLAT BOOK 2, PAGE 128 AND BOOK 3 PAGE 42.

OWNER/DEVELOPER:
CENTRAL BAPTIST CHURCH
710 JAMES LEE ROAD
FORT WALTON BEACH, FL 32548
PHONE: (850) 243-9158
FAX: (850) 664-2374

CIVIL ENGINEER:
PORTERFIELD ENGINEERING, INC.
12273 EMERALD COAST PARKWAY, SUITE 115
MIRAMAR BEACH, FL 32550
PHONE: (850) 654-0645
FAX: (850) 654-0646


DATE PREPARED:
MARCH 2008
DATE REVISED:

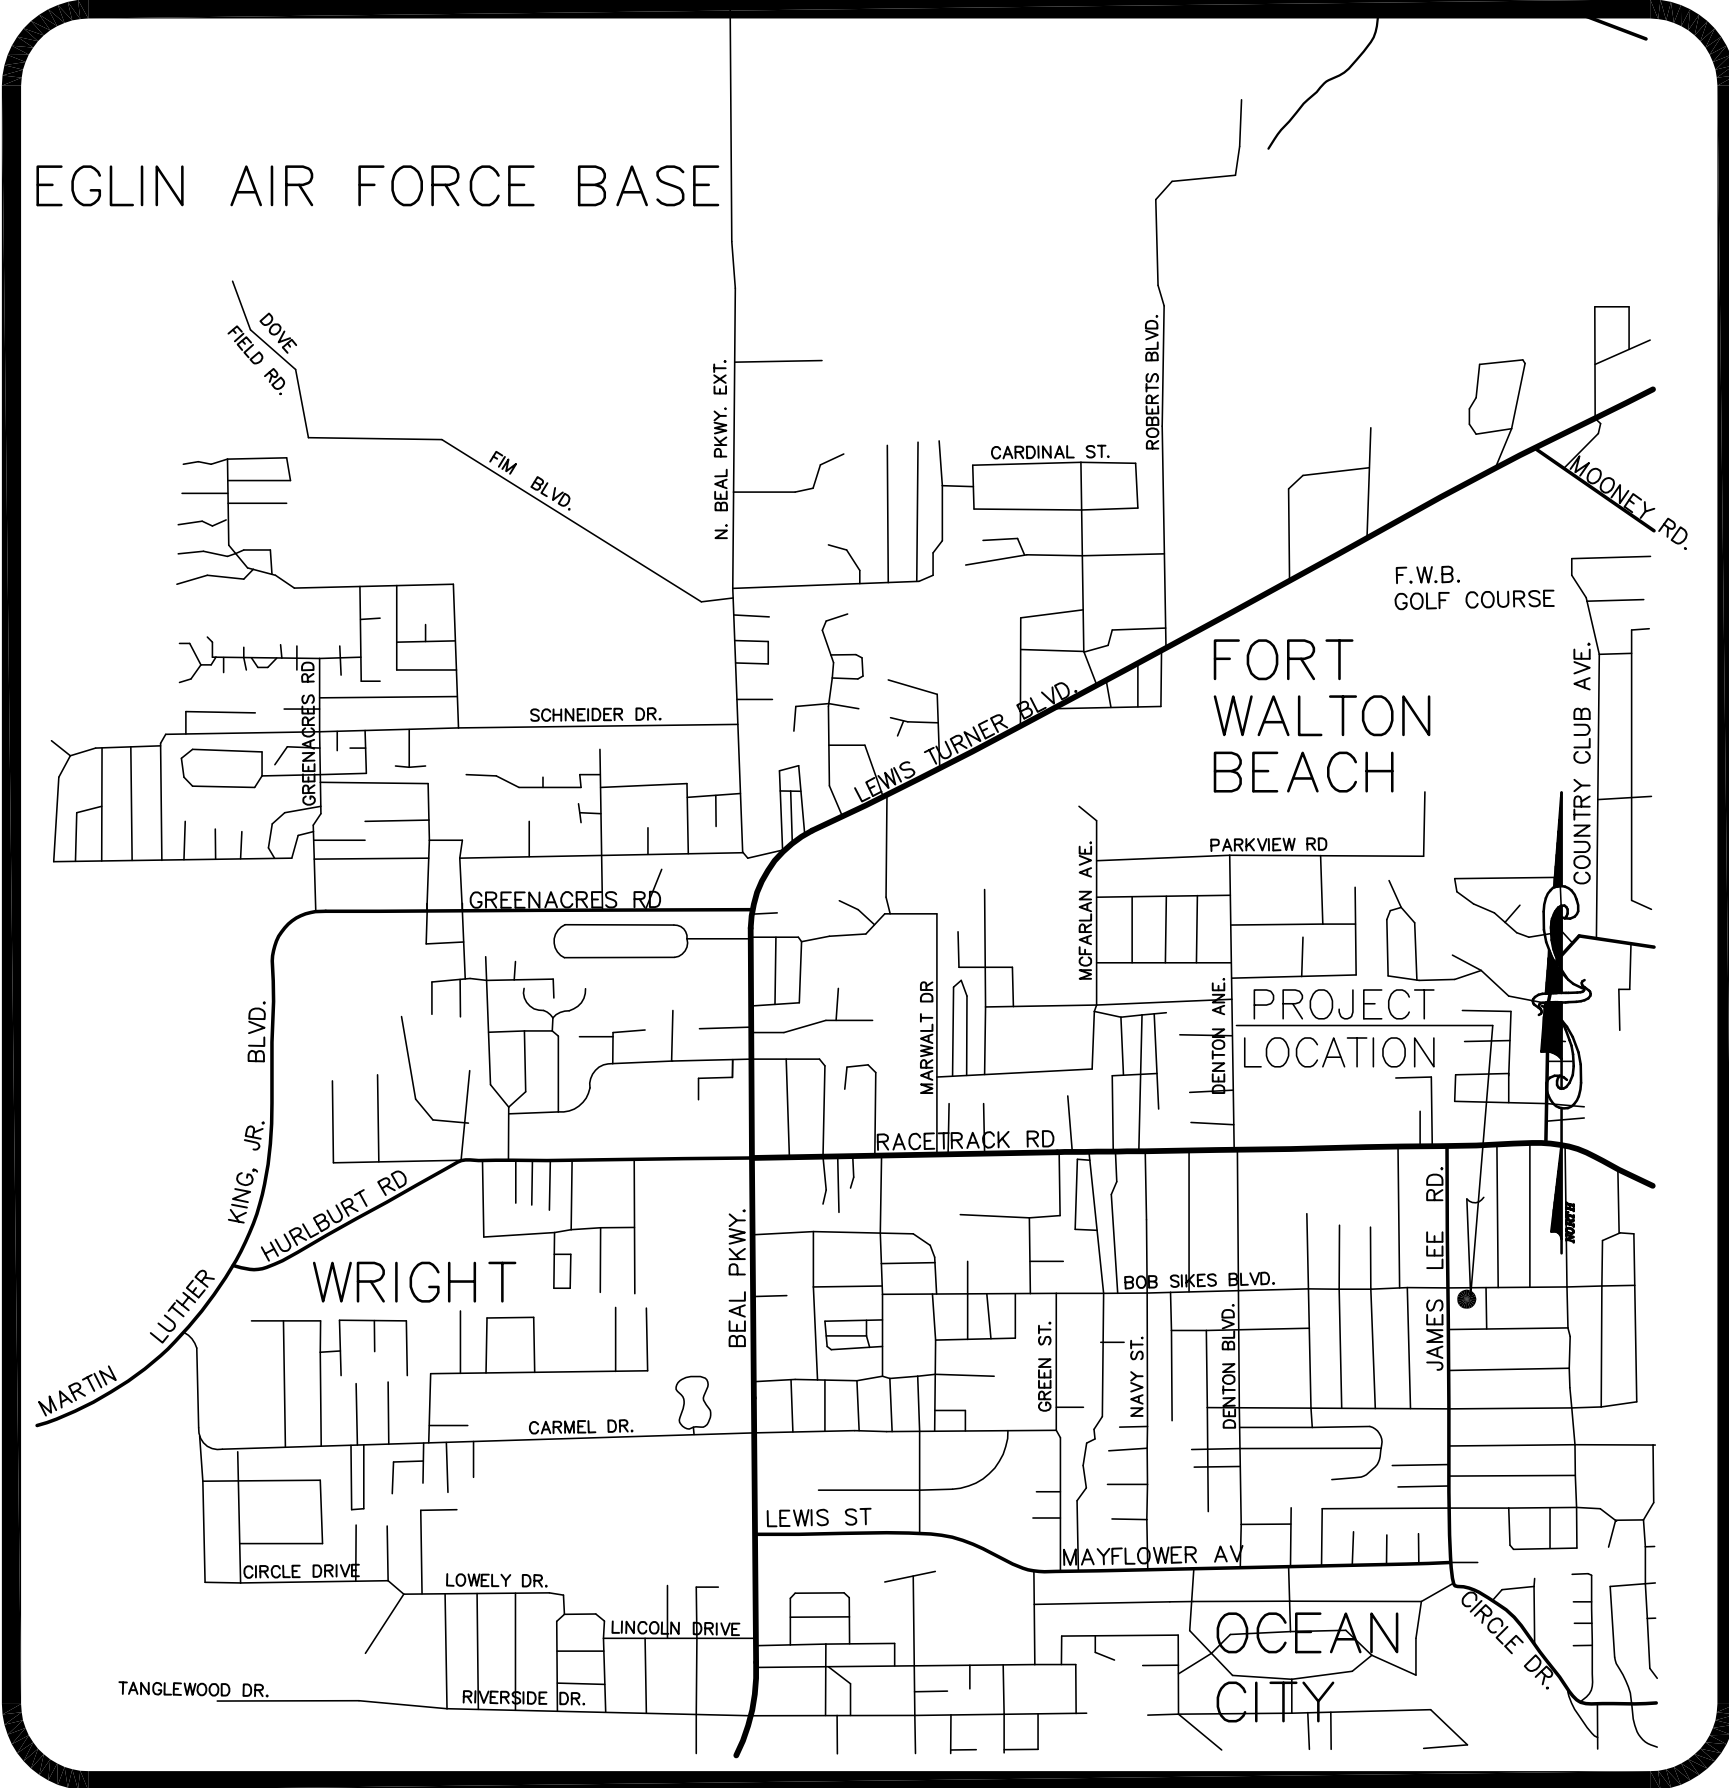

VICINITY MAP
NOT TO SCALE

- SHEET INDEX**
1. COVER SHEET
 2. EXISTING CONDITIONS AND DEMOLITION PLAN
 3. SITE & UTILITY PLAN
 4. GRADING & DRAINAGE PLAN
 5. LANDSCAPE PLAN
 6. DETAILS
 7. WATER DETAILS
 8. SEWER DETAILS
 9. GRINDER STATION DETAILS
 10. DRAINAGE AREA MAP (PRE-DEVELOPMENT)
 11. DRAINAGE AREA MAP (POST-DEVELOPMENT)

Porterfield Engineering, Inc.
Professional Engineering Services
12273 EMERALD COAST PARKWAY WEST
SUITE 115
MIRAMAR BEACH, FLORIDA 32550
Tel.: 850-654-0645
Certificate of Business No. 26307

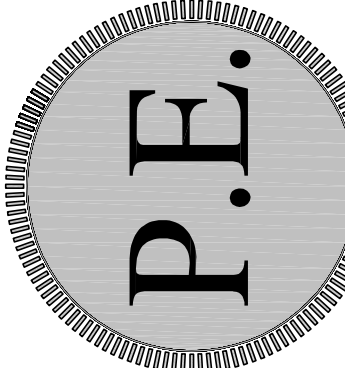

BY	REVISION	DATE

Central Baptist Church
OKALOOSA COUNTY, FLORIDA

Job No.: 07.0077.001
Date: MARCH, 2008
Designed: LHP
Drawn: JMF
Checked: LHP
DWG FILE: 07-0077-001ENG.dwg
SHEET TITLE

COVER SHEET

SEAL

RYAN A. CLEVELAND, P.E.
FL. REG. NO. 62663

The Drawings, Specifications and other Documents prepared by Porterfield Engineering, Inc. (P.E.) for this PROJECT are instruments of P.E. for use solely with respect to this PROJECT and, unless otherwise provided, P.E. shall be deemed the author of these documents and shall retain all common law, statutory and other reserved rights, including the copyright.